


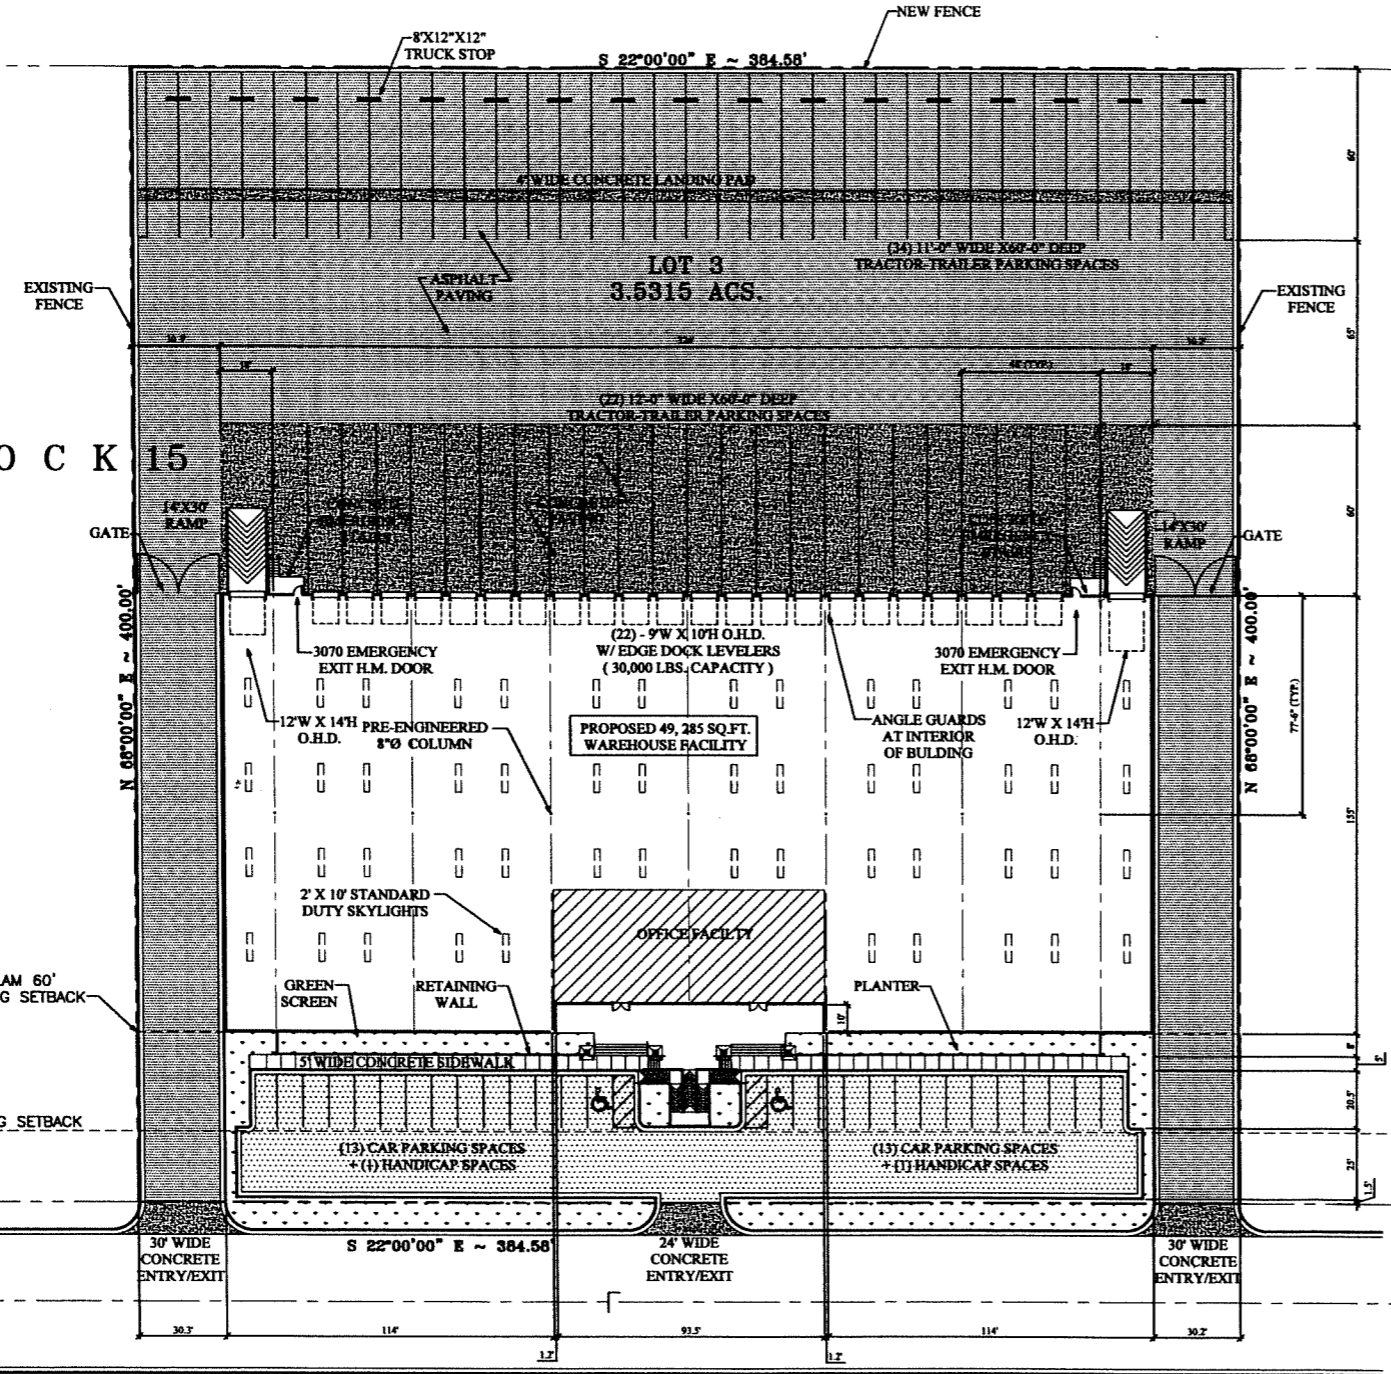

SCALE 1" = 30'

BLOCK 15




LEGEND

- ASPHALT PAVING
- GREEN AREA
- CONCRETE PAVING

CONTACT INFORMATION:

BUILDING DEPARTMENT ERASMO VILLARREAL PHONE (956) 794-1825	AMERICAN ELECTRIC POWER (AEP) BEN HINOJOSA, P.E. PHONE (956) 721-3048
ENGINEERING DEPARTMENT TERESA ESPARZA, E.I.T. PHONE (956) 791-7346	AT&T ALFREDO CASTRO PHONE (956) 727-8882
WATER UTILITIES DEPARTMENT PABLO MARTINEZ, P.E. PHONE (956) 721-2000	CENTERPOINT ENERGY SONNY LOZANO PHONE (956) 723-6352
ENVIRONMENTAL DEPARTMENT LUIS PEREZ GARCIA, P.E. PHONE (956) 794-1650	TIMEWARNER CABLE JUAN BOTELLO PHONE (956) 721-0607
FIRE DEPARTMENT JUAN MEZA PHONE (956) 795-2150	TRAFFIC DEPARTMENT TONY GARCIA PHONE (956) 795-2550

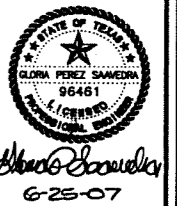

G.P.S. ENGINEERING, L.L.C.
LAND PLANNING CIVIL DESIGN
CONSTRUCTION MANAGEMENT

644 ZOOKE DRIVE LAREDO, TEXAS 78045
PHONE (956) 722-3409
FAX (956) 722-3409

**KILLAM BUILDING "M"
LOT 3, BLOCK 15
KILLAM INDUSTRIAL PARK
UNIT 10
LAREDO, TEXAS**

SITE PLAN

SCALE	1"=30'
DATE	JUNE 25, 2007
REVISIONS	
DRAWN BY	G.P.S.
CHECKED BY	G.P.S.
FILE NAME	
PROJECT NUMBER	2007-005
SHEET	